



MOBILE SENTRY ONE TRAILER – 6' X 4' X 4' TALL

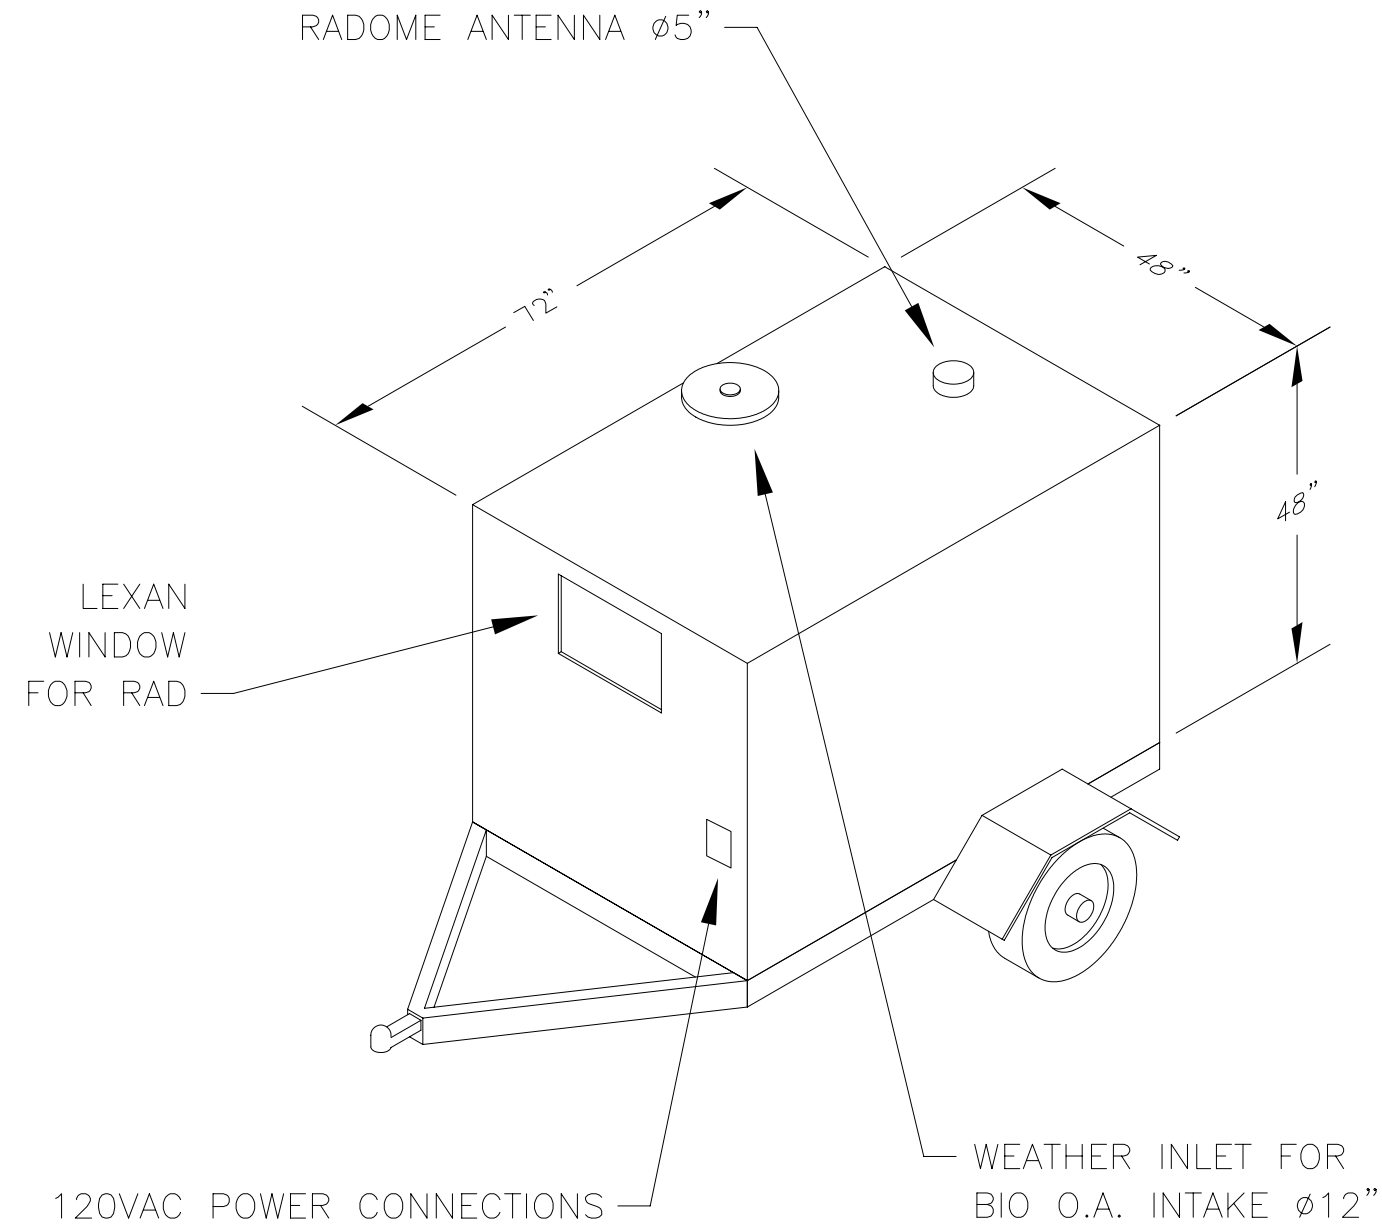

- ASO – ALPHA SENTRY ONE PANEL 24" X 24" X 12"
- BIO – BIO DETECTOR PANEL 12" X 10" X 12"
- COMM – COMMUNICATIONS PANEL 24" X 24" X 10"
- CSA – CHEMICAL SENSOR ARRAY PANEL 24" X 24" X 12"
- RAD – RADIATION AREA DETECTOR PANEL 14" X 10" X 7"
- UPS – UNINTERRUPTIBLE POWER SOURCE / BATTERY

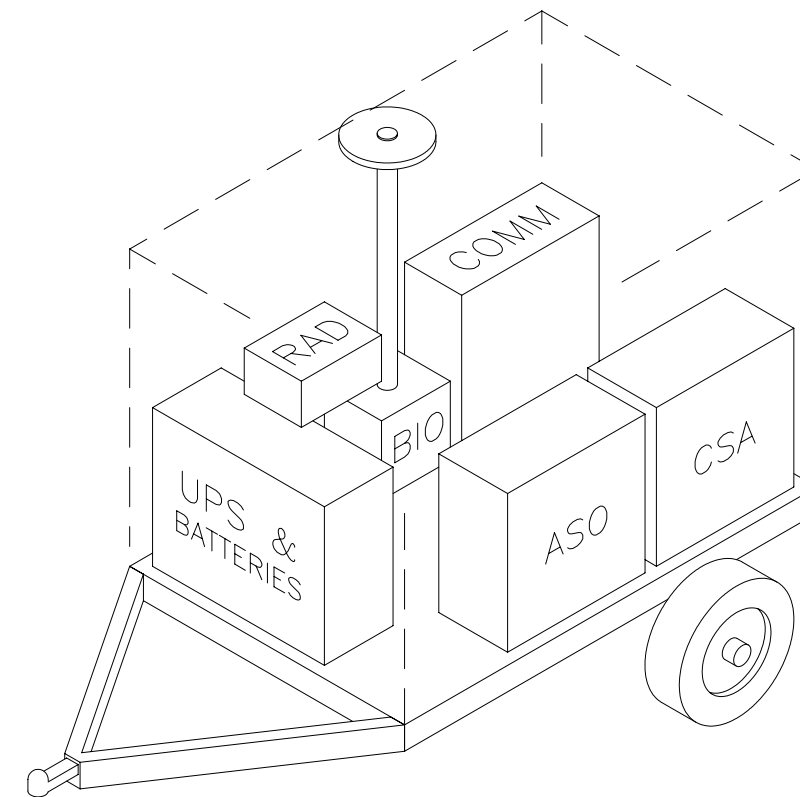

NOTES, UNLESS OTHERWISE SPECIFIED:

- 1.
- 2.
- 3.
- 4.
- 5.
- 6.

REVISIONS

REV	BY	DATE	DESCRIPTION
0	DV	6/09	CONCEPTUAL LAYOUT



ALL DIMENSIONS ARE IN INCHES - DO NOT SCALE DRAWING

THE INFORMATION HEREIN CONTAINED SHALL NOT BE USED FOR THE BENEFIT OF ANYONE EXCEPT BUILDING PROTECTION SYSTEMS INC., NOR SHALL IT BE DISCLOSED IN WHOLE OR IN PART TO OTHERS OUTSIDE THE RECIPIENT'S ORGANIZATION, EXCEPT IN CONNECTION WITH THE SALE AND USE OF THE RESPECTIVE BUILDING PROTECTION SYSTEMS INC. EQUIPMENT, WITHOUT THE WRITTEN PERMISSION OF BUILDING PROTECTION SYSTEMS, INC.


DRAWN BY:	DV	6/09
DESIGNED BY:	JP	6/09

PROJECT TITLE: BUILDING PROTECTION SYSTEMS, INC.



DRAWING TITLE: MOBILE SENTRY ONE TRAILER CONCEPTUAL LAYOUT

CUSTOMER: BUILDING PROTECTION SYSTEMS, INC.


SCALE: 1"=2'	SIZE: B	DRAWING NUMBER: 1016-D-CPT	SHEET: 1 OF 1
--------------	---------	----------------------------	---------------

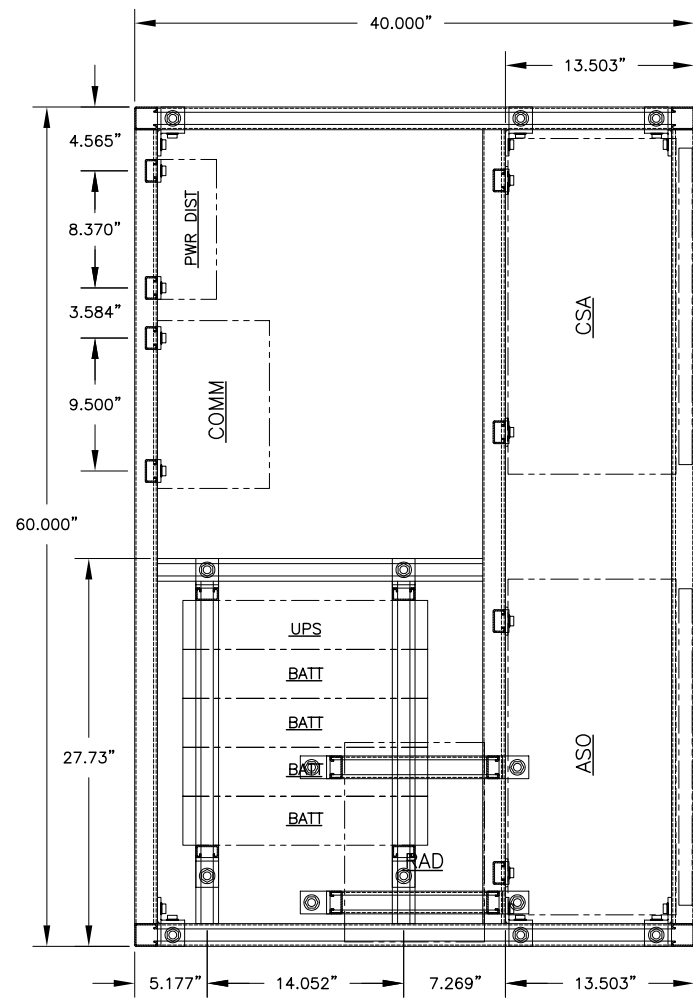

VIEW A-A

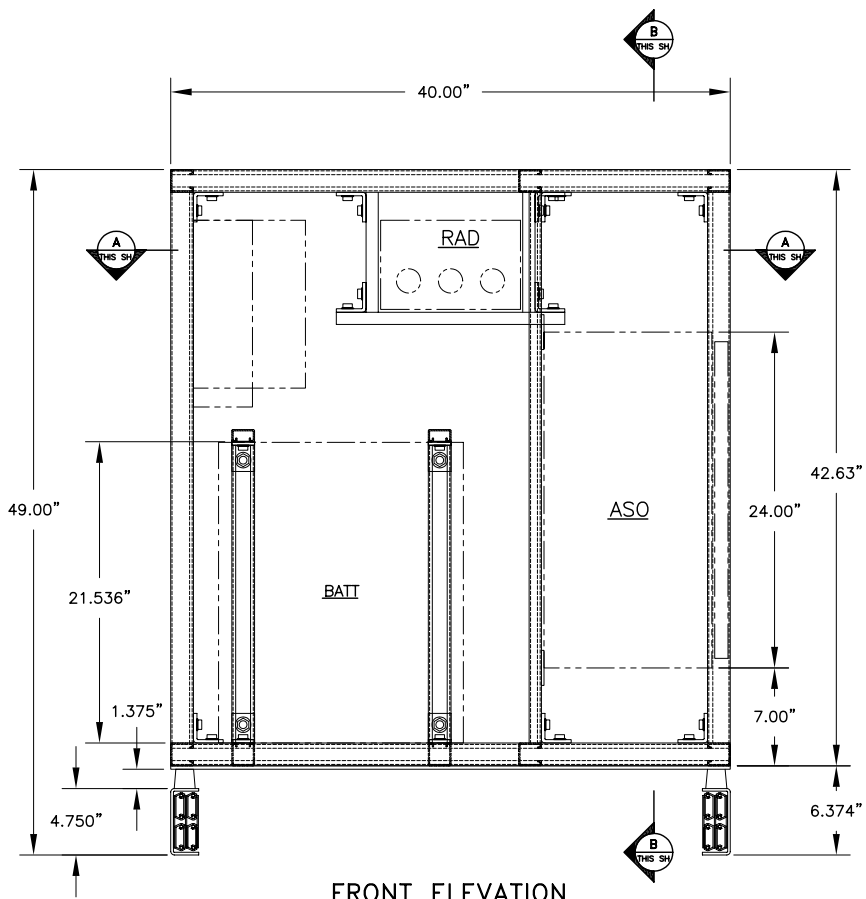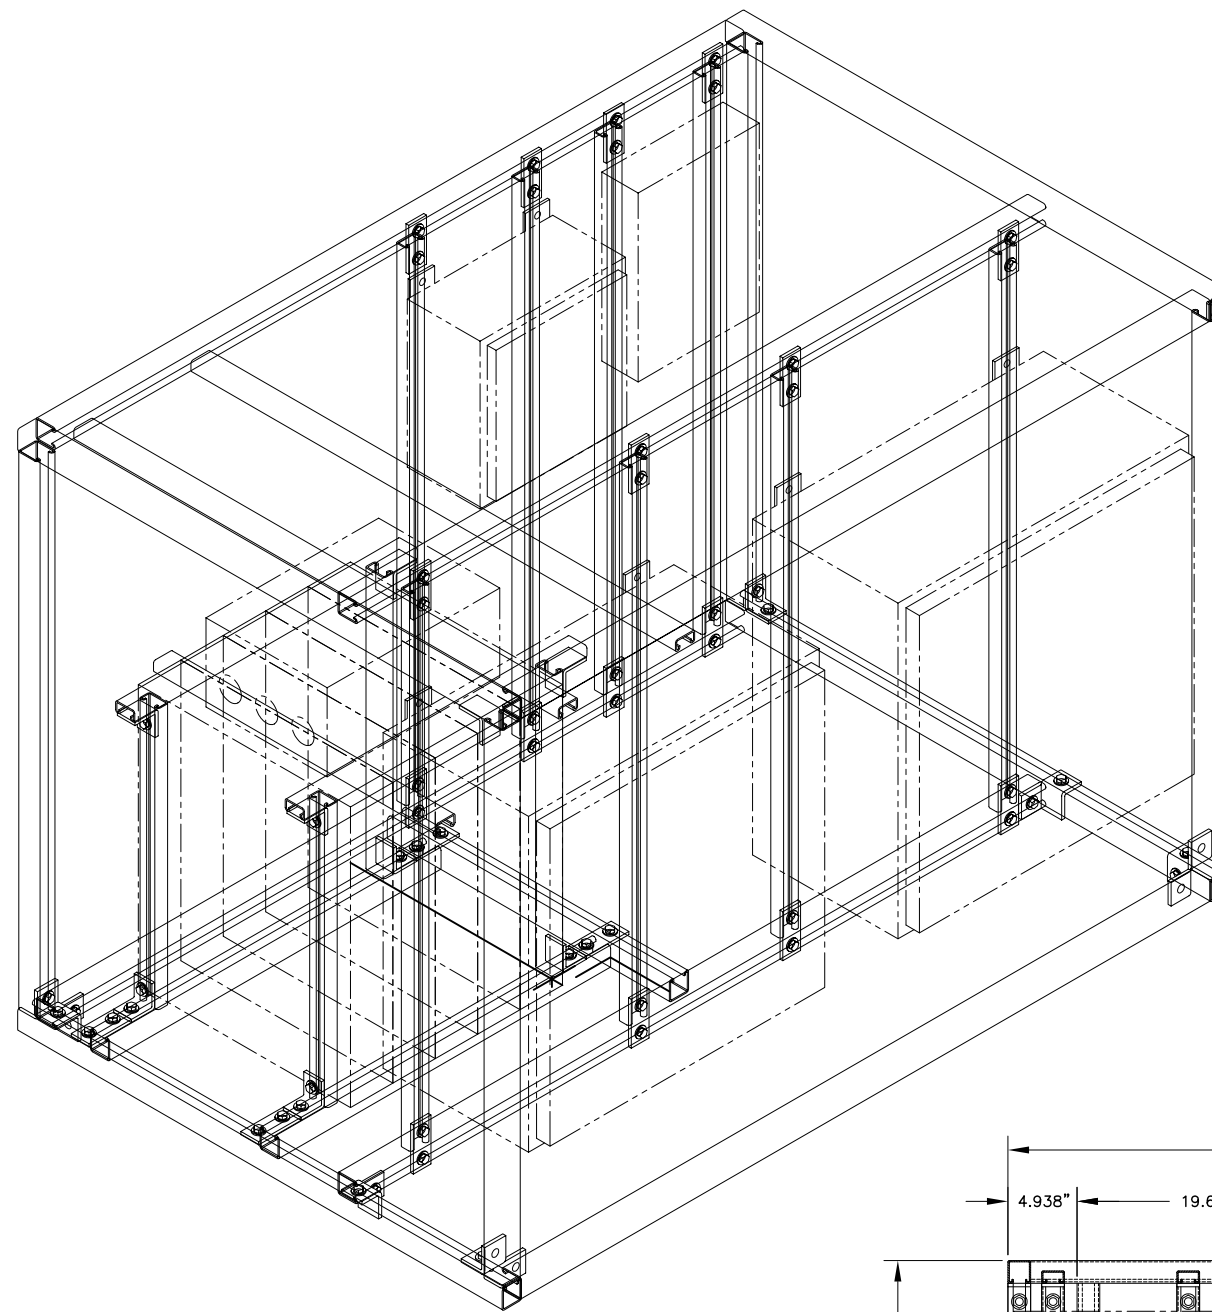

FRONT ELEVATION

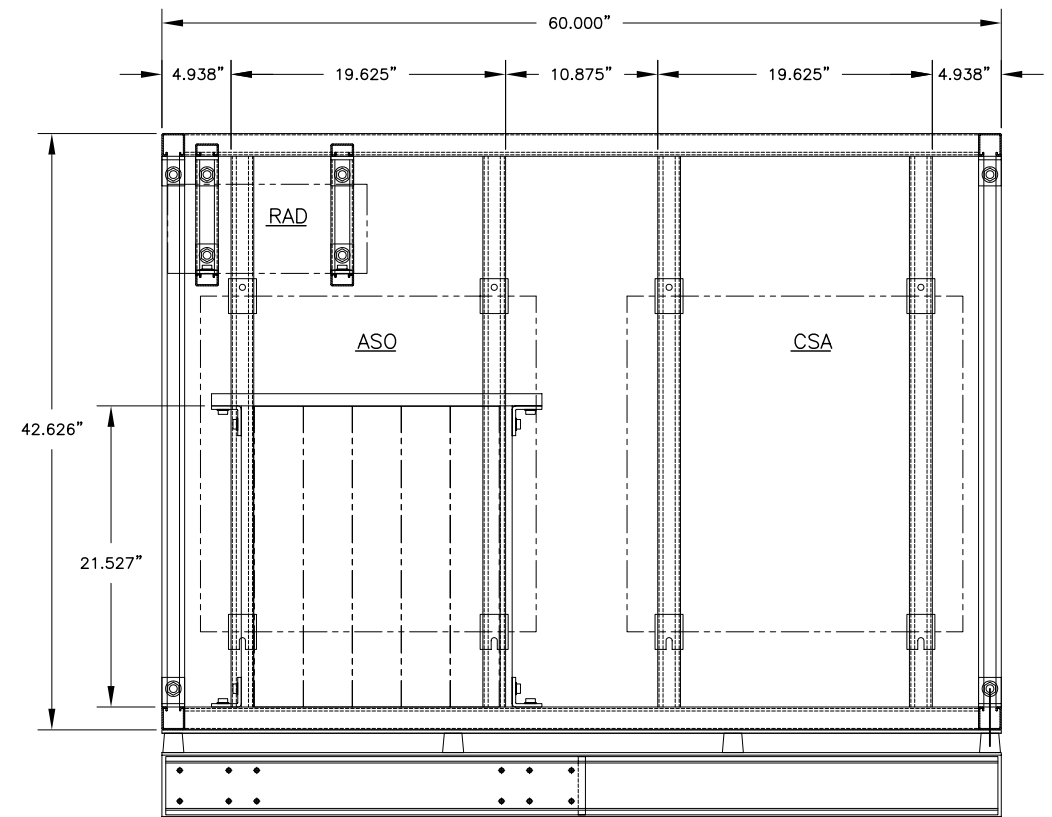

VIEW B-B